

EQUIPMENT SCHEDULE															
ITEM NO.	QTY.	DESCRIPTION	MANUFACTURER	MODEL NO.	PLUMBING				ELECTRICAL						
					N.S.F. E.T.L.	U.L. E.T.L.	WATER HW. OW. DIR. INCH.	WASTE INCH.	VOLTS	PHASE	LOAD AMPS	CONDUIT SIZE	WIRE SIZE	RECEPTACLE SPEC	A.F.F.
1	3	HOT DRINK MACHINE	NEWCO	NKDPAF					208V	1	24		YES	4 PIN TWIST LOCK	
2	1	DROP IN HAND SINK	UNIVERSAL	JM-01-10144-R8			1/2"	1/2"							
3	1	2 SIDED SPLIT GRILL	PROGRILL	SL1577					120V	1	18		YES	5-20P	
4	1	3 SELECT HOT CAPPUCCINO MACHINE	BUNN	PUSH N HOLD MODEL					120V	1	18		YES	5-20P	
5	1	1/2" CONVEYOR TOASTER	BELLECO	JTS-HC					208V	1	17.3		YES	6-30P	
6	1	MILLWORK	MILLWORK SUPPLIER	CUSTOM											
7	1	FOOD PREP TABLE	BEVERAGE AIR	SPE72-30M					120V	1	9.6		YES	5-15P	
8	1	TABLE													
9	1	GRAVITY FEED SLICER	BERKEL	827A-PLUS					120V	1	4		YES	5-15P	
10	1	EXISTING STAINLESS STEEL HAND SINK		CUSTOM			1/2"	1/2"							
11	1	EXISTING STAINLESS STEEL TABLE W/ SINK		CUSTOM											
12	1	EXISTING STAINLESS STEEL TABLE W/ SINK		CUSTOM											
13	1	EXISTING GAS RANGE													
14	2	FULL SIZE GAS CONVECTION OVEN	BLODGETT	SHO-G					120V	1	6		YES	P&S 2086 GFCI	
15	1	ELECTRIC COUNTER CONVECTION STEAMER	SOUTHBEND	R24-S					208V	3	12 / PHASE		NO		
16	1	NEW HOOD	CAPTIVE AIR												
17	3	CHECK OUT SCALE	DIGI	DS-880					120V	1	-		YES		
18	3	TOUCH POS	TOSHIBA	ST-A10					120V	1	1.3		YES		
19	1	AMANA COMMERCIAL MICROWAVE	AMANA	RCS10TS					120V	1	13		YES	5-15P	
20	2	COKE 3DR. COOLER							120V	1	13		NO		
22	3	EXISTING COOLER AND FREEZER TO REMAIN													
23	1	EGG STATION	ROUND UP	ES-604					208V	1	11.4		YES	6-20P	
24	1	COLD BUFFET INSERT	ASTOR						120V	1	30				
25	1	STEAMER INSERT	ASTOR	CUSTOM			1/2"		110V	208V	1	3434			
26	1	STEAMER INSERT (SOUP INSERT DROP IN)	ASTOR	CUSTOM			1/2"		110V	208V	1	19			
27	3	48" X 18" SHELVING UNITS	METRO	1848BR											
27A	5	48" X 18" SHELVING UNITS	METRO	1848BR											
28	5	72" X 18" SHELVING UNITS	METRO	1872BR											
29	2	36" X 18" SHELVING UNITS	METRO	1836BR											
29A	1	36" X 18" SHELVING UNITS	METRO	1836BR											
30	1	24" X 18" SHELVING UNITS	METRO	1824BR											
31	1	EXISTING ISLAND TABLE W/ SINK		CUSTOM											
32	2	FINISHED PRODUCT MOVEABLE RACK	KELMAX	4#100											
33	1	HEATED HOLDING/PROOFING CAB	METRO	CS37-HFC-U					120V	1	16.7		YES	5-20P	
34	1	COFFEE STATION MILLWORK	MILLWORK SUPPLIER	CUSTOM											
35	8	COFFEE DISPENSER													
36	1	HOT WATER TOWER W/ SURROUND	BUNN	CUSTOM					208V	1	38.7		NO		
37	1	EXISTING 3 COMP SINK													
38	8	COFFEE DRIP TRAY AND STAND	BUNN												
39	3	18"X30" STAINLESS WALL SHELF	METRO												
40	5	18"X72" STAINLESS WALL SHELF	METRO												
41	2	18"X48" STAINLESS WALL SHELF	METRO												
42	3	EMPLOYEE LOCKERS	WIN-HOLT	WL-68 (156196)											
43	1	MOP SINK	ZURN	ZRN2199624			1/2"	1/2"	4"						
44	1	18"X24" STAINLESS WALL SHELF	METRO												
45															
46	1	HOLDING BIN	PRINCE CASTLE	PHB72PT-70B					120V	1	10		YES	5-20P	
47															


* NOTE: UNIT HAS TWO IDENTICAL SECTIONS

KEYED NOTES

- ① EXISTING 30 A DISCONNECT FOR COOLER/FREEZER COMPRESSORS TO BE REUSED.
- ② REUSE EXISTING 120/208V, 3PH-600A FUSED SWITCH FOR NEW SERVICE. CONTRACTOR TO VERIFY AND CONFIRM 600A AVAILABILITY.
- ③ TELEPHONE BOARD
- ④ CONDUIT TERMINATION TO OWNERS PATCH PANEL
- ⑤ KITCHEN HOOD FIRE SUPPRESSION
- ⑥ KITCHEN HOOD
- ⑦ ABOVE COUNTER OUTLETS
- ⑧ TOASTER
- ⑨ MICROWAVES
- ⑩ QUAD OUTLET AT 7"-6"
- ⑪ PATCH PANEL 24 PORT.
- ⑫ OUTLET IN SOFFIT FOR MENU BOARDS (TV MONITORS)
- ⑬ THREE(3) CAT 6 CABLES IN 3" CONDUIT BACK TO PATCH PANEL-SEE SHEET E8. TERMINATE AT PATCH PANEL AD RS232 DATA PORT JACK
- ⑭ ONE(1) CAT 6 CABLES IN 1" CONDUIT BACK TO PATCH PANEL-SEE SHEET E8. TERMINATE AT PATCH PANEL AD RS232 DATA PORT JACK MOUNTED IN SOFFIT.
- ⑮ JUNCTION BOX WITH SWITCH FOR NEW SIGNS. LOCATED IN CEILING SPACE AT FRONT STORE PANEL. PROVIDE PROGRAMMABLE TIMER FOR SIGNAGE.
- ⑯ PROVIDE SHUT OFF INTERFACE WITH ANSUL SYSTEM FOR ALL EQUIPMENT UNDERNEATH HOOD, THRU SHUNT TRIP BREAKERS.
- ⑰ PROVIDE SHUNT TRIP UNDER HOOD.

NOTES

1. SEE SHEET E6 FOR DATA/TELEPHONE REQUIREMENTS.
2. ALL WIRING SHALL BE IN CONDUIT AND COMPLIANT WITH CHICAGO CODE FOR RETURN AIR PLENUMS.
3. COORDINATE FIRE ALARM SYSTEM REQUIREMENTS WITH CITY OF CHICAGO FIRE PREVENTION DEPARTMENT AND LANDLORD. ALL FIRE ALARM WIRING TO BE IN CONDUIT.

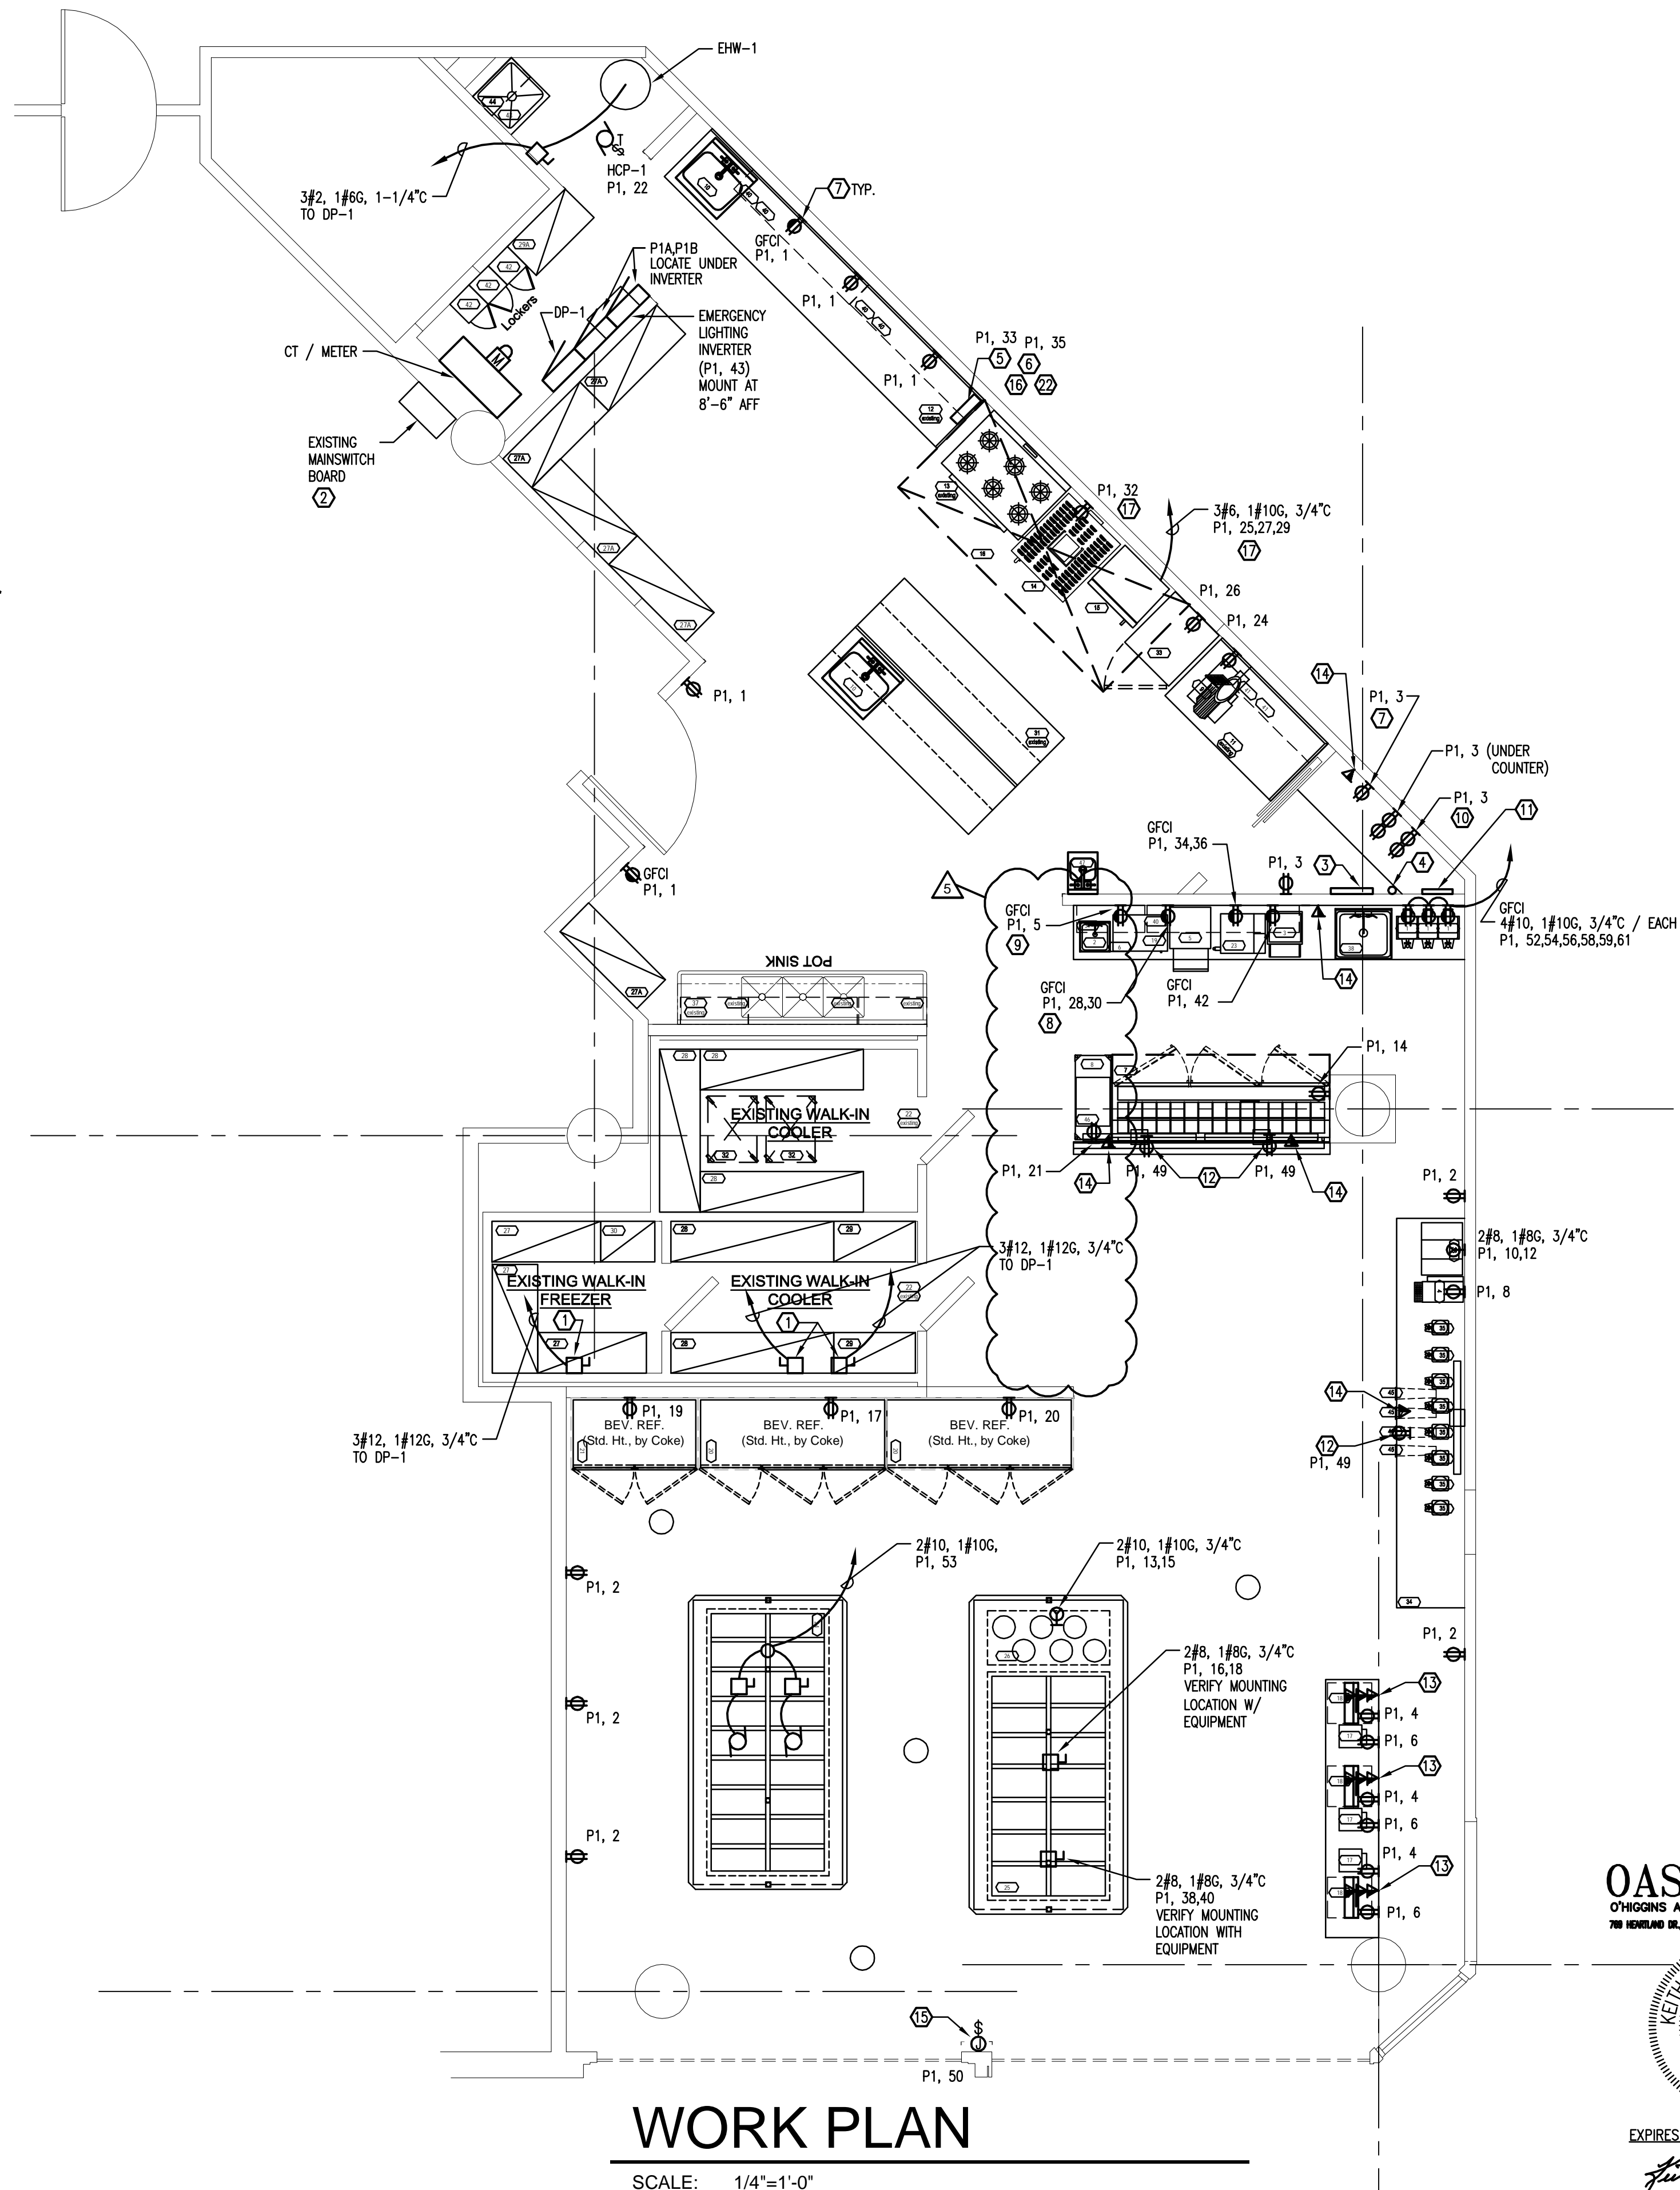

WORK PLAN

SCALE: 1/4"=1'-0"



E-mail: thadgleason@gleasonarchitectpc.com

THESE DRAWINGS, INCLUDING ALL DESIGNS, DETAILS, SPECIFICATIONS AND INFORMATION, ARE THE SOLE PROPERTY AND COPYRIGHT OF GLEASON ARCHITECTS, P.C. AND ARE FOR USE ON THIS SPECIFIC PROJECT AND SHALL NOT BE USED ON ANY OTHER WORK WITHOUT THE AGREEMENT AND WRITTEN PERMISSION OF GLEASON ARCHITECTS, P.C.

ISSUED	DATE
FOR APPROVAL	
FOR PERMIT	
FOR BID	
FOR CONST.	

REVISIONS	DATE
△ REVISION #1	11/12/14
△ REVISION #2	12/29/14
△ REVIEW COMMENTS	01/12/15
△ MARCELLOS REVISIONS	01/22/15
△ REVIEW COMMENTS	02/11/15
△ REVISION #3	03/25/15

PROJECT: **Marcellos Market & Deli**
 100 W Randolph Street
 Chicago, IL
 CLIENT: **Fadi Karchi**
 Canada

JOB NO. 04-022
 DATE 10/15/14
 FILE
 PLOT SCALE
 OWNER APPROVAL

Signature _____
 Date _____

SHEET TITLE
**Floor Plan
 Power -
 Electrical**

SHEET NUMBER
E2

OAS, LLC
 O'HIGGINS AND ARNOLD SUSTAINABILITY, LLC
 700 HENRIAD DR., UNIT A SIOUX GROVE, ILLINOIS 62554



EXPIRES NOVEMBER 30, 2015

Keith O'Higgins