




NEVIN HEDLUND ARCHITECTS, INC.

7985 Lake Street, River Forest, Illinois 60305
Telephone: 708.771.7117 Facsimile: 708.771.7124
Website: www.HedlundArchitects.com

PROJECT TEAM

OWNER

WINTHROP MANAGEMENT, L.P.
ATRIUM MALL LLA
100 WEST RANDOLPH STREET, SUITE 210
CHICAGO, IL 60601

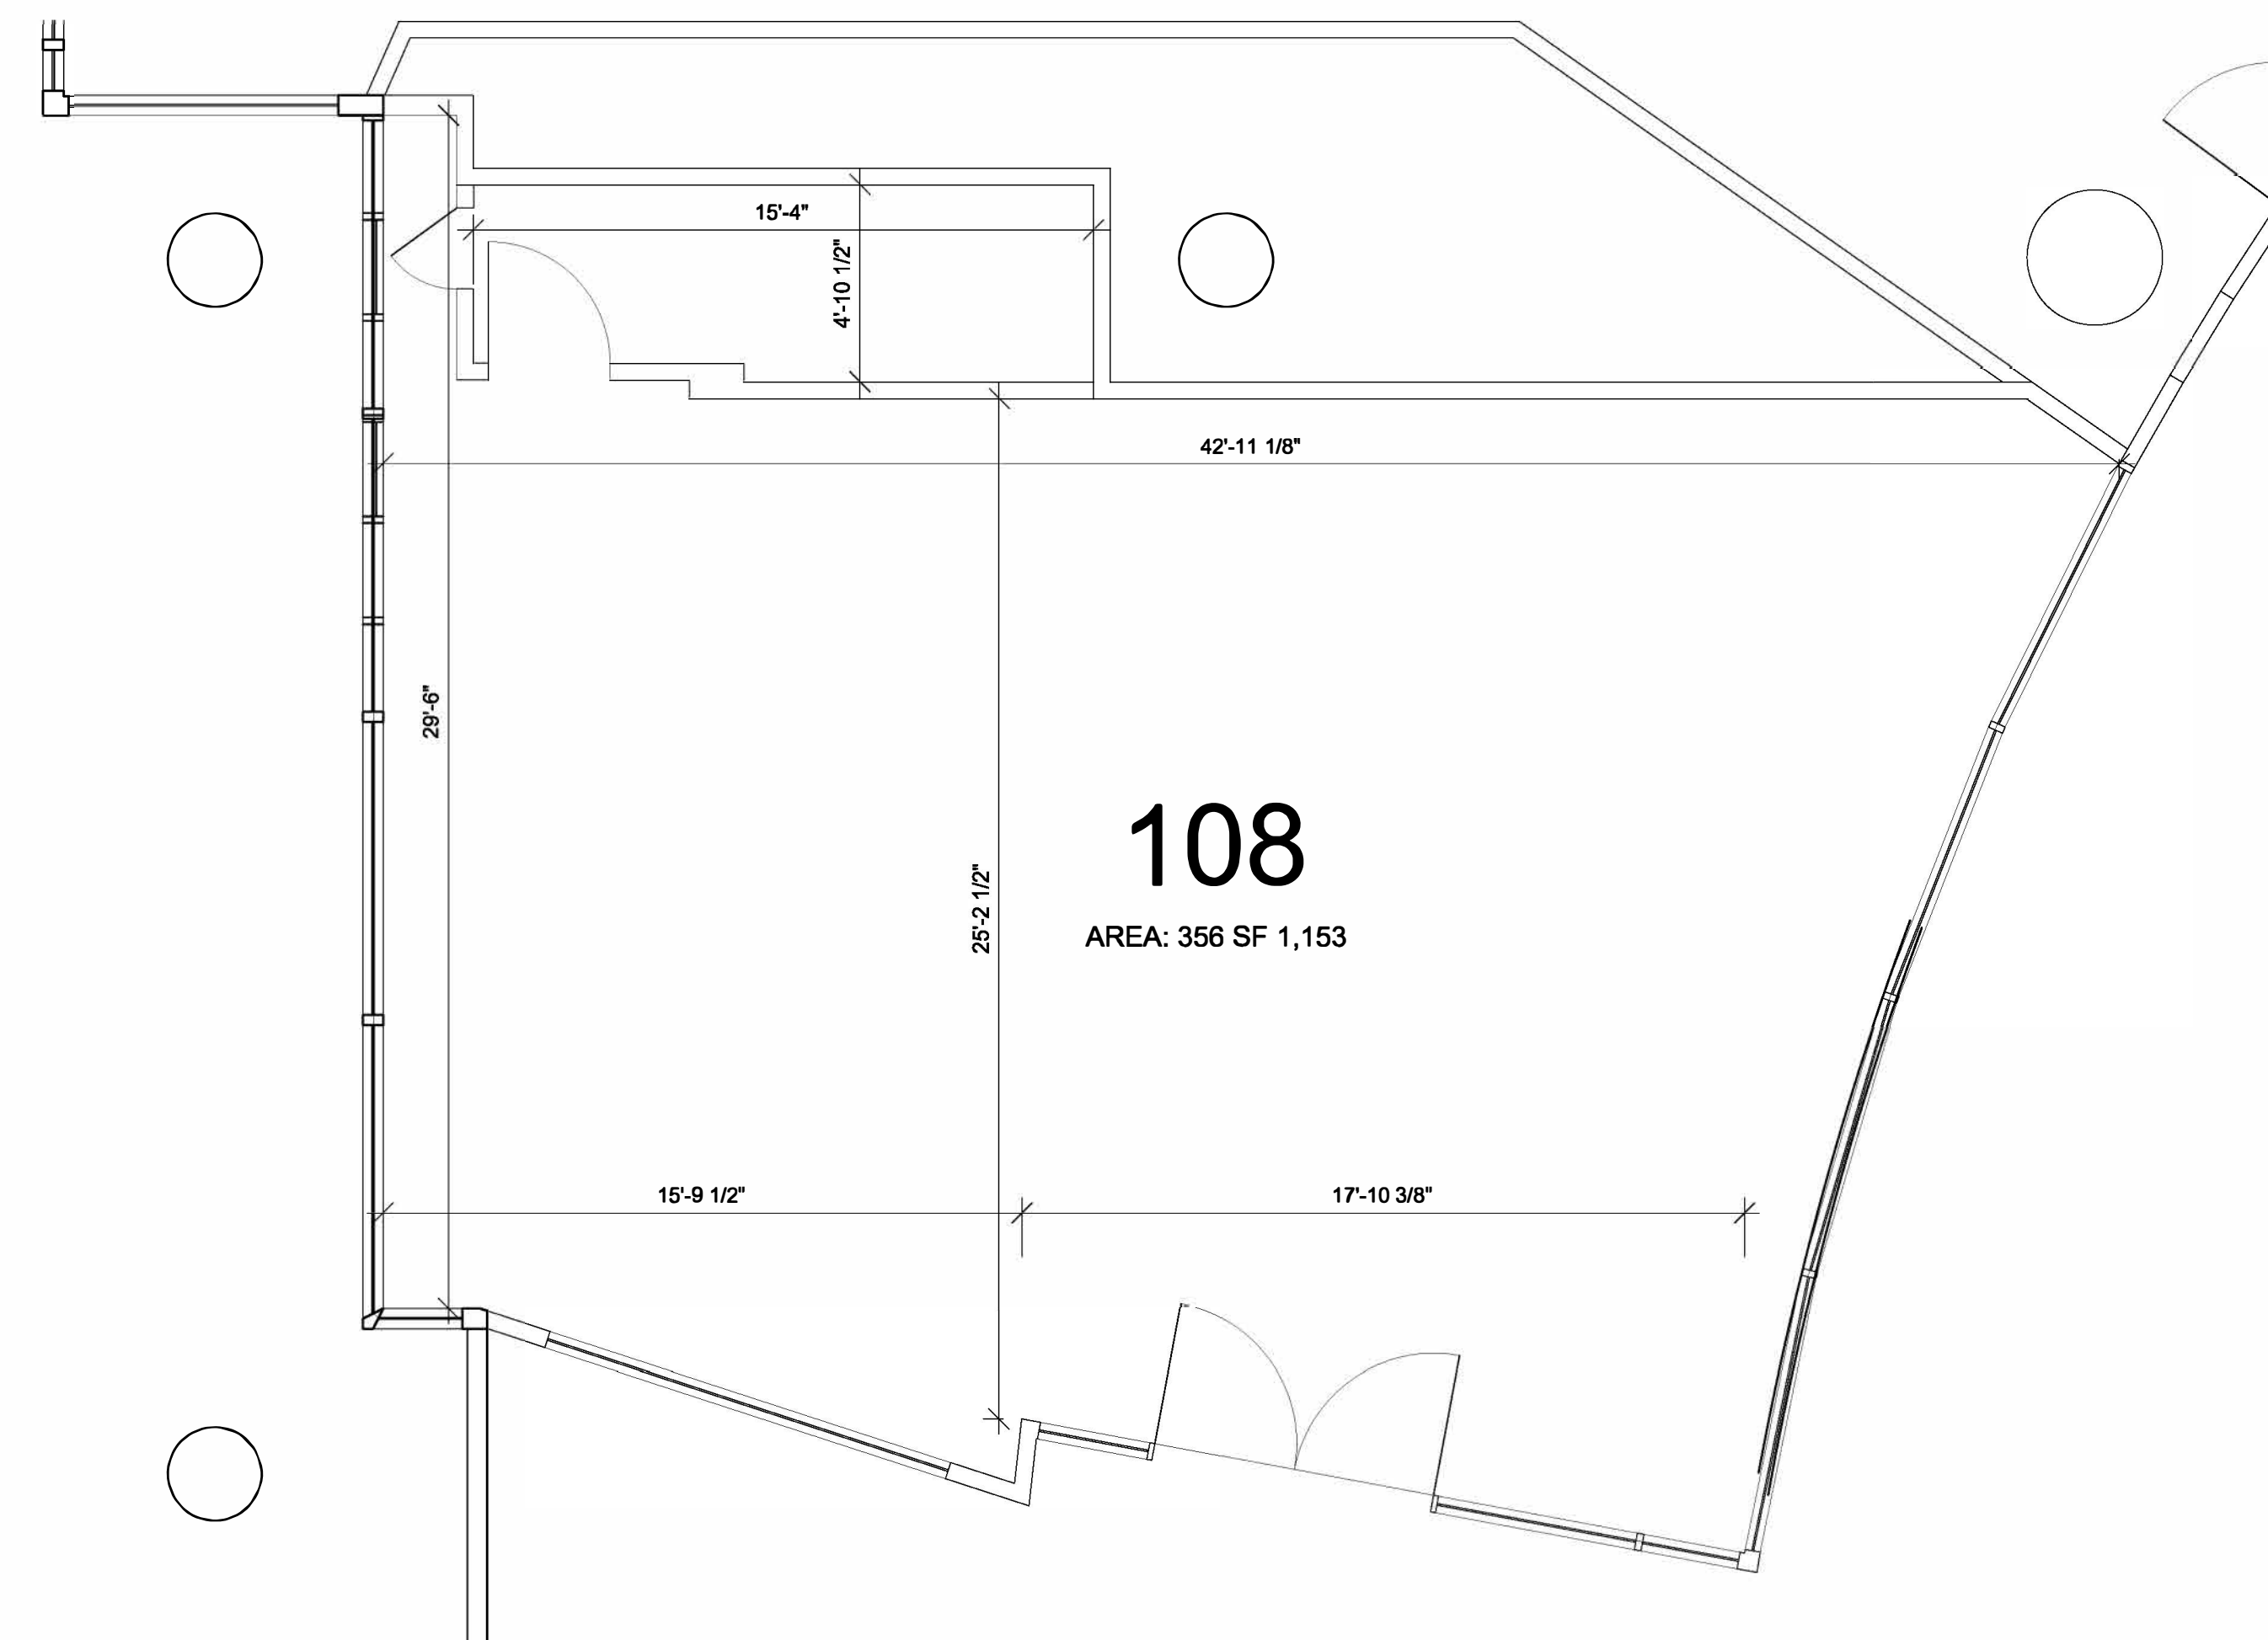

1 1ST FLOOR PLAN - 108

SCALE: 1/4" = 1'-0"

N

[illegible]

ATRIUM MALL
100 W. RANDOLPH

CHICAGO, IL 60601

SUITE 108

Job No.	024-000-20
---------	------------

Date	08/13/20
------	----------

Drawn by	NHA
----------	-----

A1.01

Scale	
-------	--